



NOTES:
 1. ALL COORDINATES SHOWN ON THIS DRAWING ARE PRELIMINARY AND ARE SUBJECT TO A PLUS OR MINUS ADJUSTMENT OF 30 FEET.

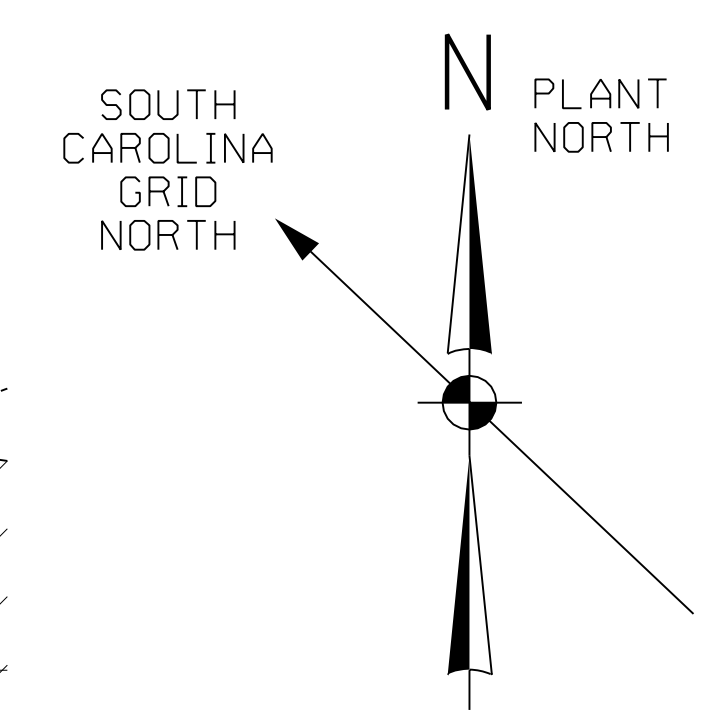

DRAWN BY COK	ENGINEER
CHECKED BY	PROJECT ENGINEERING MANAGER R.J. MARTIN
LEAD DESIGNER	PROJECT MANAGER J.T. HICKSON
PRELIMINARY STATUS	DATE REPRESENTS GENERAL DESIGN CONCEPTS BASED ON ASSUMPTIONS.
DATE	REVIEWED NOT CHECKED.
LDE S.G. WAINWRIGHT 04-04-07	
APPROVED STATUS	DATE REPRESENTS REVIEWED AND APPROVED DESIGN. ANY PORTION MARKED "HOLD" RETAINS PRELIMINARY STATUS.
DATE	
LDE	

CERTIFICATE OF AUTHORIZATION PROFESSIONAL ENGINEER'S SEAL

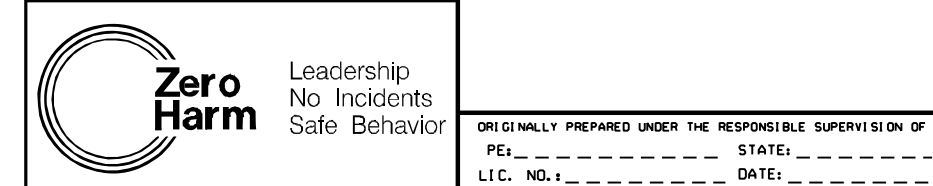

PEE DEE GENERATING STATION / UNIT 1



GENERAL ARRANGEMENT
 UNIT 1 AND 2
 SITE PLAN

ISSUED FOR INFORMATION ONLY 04-04-07 COK	LEAD DISC ENGINEER
	ENGINEER/TECH. SPEC.
	LEAD DESIGNER
	CHECKED
DATE	DRAWN
REV	REV

SCALE	DWG SIZE	JOB NO.
1" = 200'	D (24' x 36')	537909
WORLEYPARSONS DWG. NO.		REV
PEDE-1-DW-CH-002-5001		A

△	FAC	PIPING	I & C	ELECT	MECH	CIVIL	STRUC	△	FAC	PIPING	I & C	ELECT	MECH	CIVIL	STRUC	△	FAC	PIPING	I & C	ELECT	MECH	CIVIL	STRUC	△	FAC	PIPING	I & C	ELECT	MECH	CIVIL	STRUC	△	FAC	PIPING	I & C	ELECT	MECH	CIVIL	STRUC	△
---	-----	--------	-------	-------	------	-------	-------	---	-----	--------	-------	-------	------	-------	-------	---	-----	--------	-------	-------	------	-------	-------	---	-----	--------	-------	-------	------	-------	-------	---	-----	--------	-------	-------	------	-------	-------	---